


PRELIMINARY DRAWING - FOR LAYOUT PURPOSES ONLY

REVISIONS			
REV	DESCRIPTION	DATE	BY

NOTE 1: Do not scale drawing. This drawing is for general truck configuration only. All items and dimensions shown are approximate and may vary with final production. The drawing may not provide illustration for all items in the specification. In all situations where the drawing may contradict the specifications, the specifications shall prevail. This drawing and all data herein are provided as confidential materials and shall not be reproduced without written consent of the manufacturer.

NOTE 2: Chassis frame height will change due to axle characteristics, loading and tire dimensions which will effect the overall height dimension shown. Any overall height restrictions should take this into consideration and allow approximately 2-3 inches of tolerance.

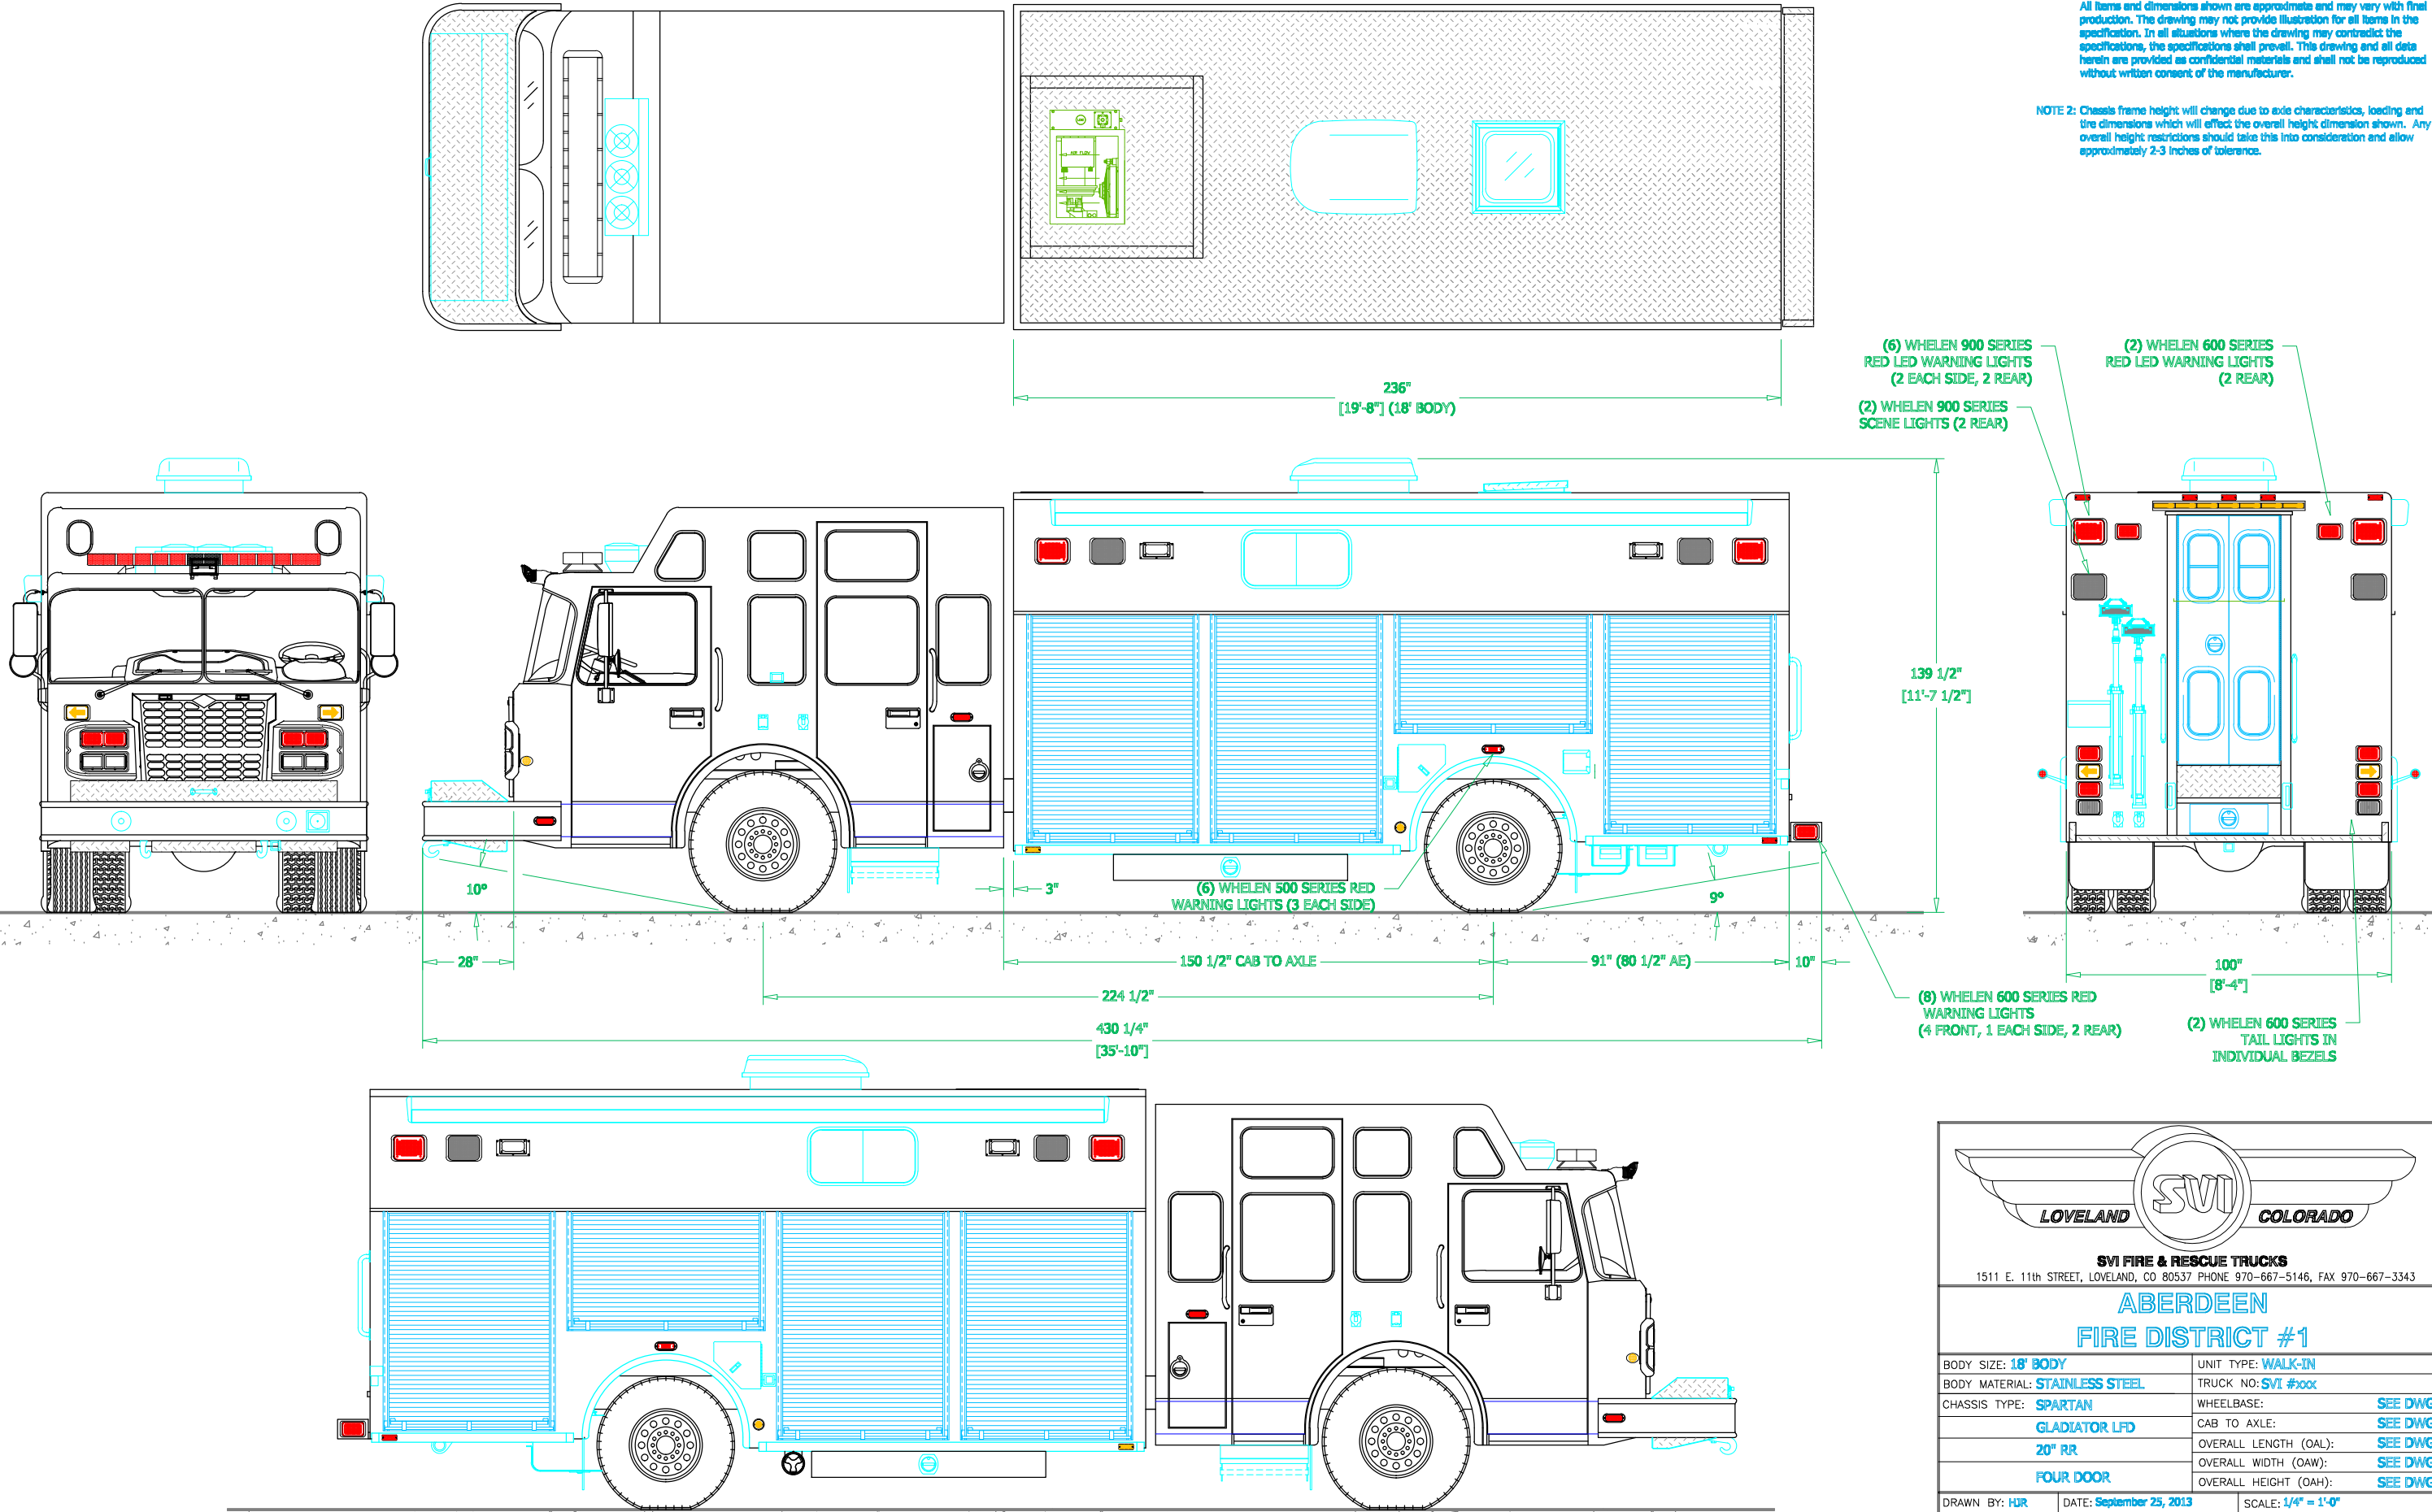



LOVELAND SVI COLORADO

SVI FIRE & RESCUE TRUCKS

1511 E. 11th STREET, LOVELAND, CO 80537 PHONE 970-667-5146, FAX 970-667-3343

ABERDEEN

FIRE DISTRICT #1

BODY SIZE: 18' BODY	UNIT TYPE: WALK-IN
BODY MATERIAL: STAINLESS STEEL	TRUCK NO: SVI #100X
CHASSIS TYPE: SPARTAN	WHEELBASE: SEE DWG
GLADIATOR LFD	CAB TO AXLE: SEE DWG
20" RR	OVERALL LENGTH (OAL): SEE DWG
FOUR DOOR	OVERALL WIDTH (OAW): SEE DWG
	OVERALL HEIGHT (OAH): SEE DWG

DRAWN BY: **HJR**

DATE: **September 25, 2013**





SCALE: **1/4" = 1'-0"**

DRAWING NO: **Aberdeen_NJ_hr_PCM1**

SHEET **1** OF **3**

REVISIONS			
REV	DESCRIPTION	DATE	BY

The diagram illustrates the electrical layout of the vehicle. On the left, the battery and alternator are shown. The battery is connected to a 12V panel, which in turn connects to various 12V components including the engine, lights, and horn. A 120/240V panel is also shown, connected to the 12V panel and providing power to the 120/240V components. The diagram uses solid lines for main power lines and dashed lines for control or signal lines. Components are labeled with their respective voltages and functions.

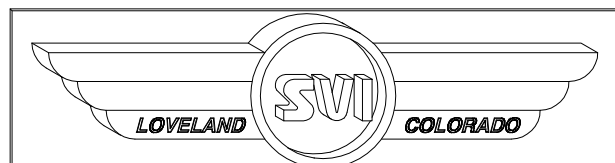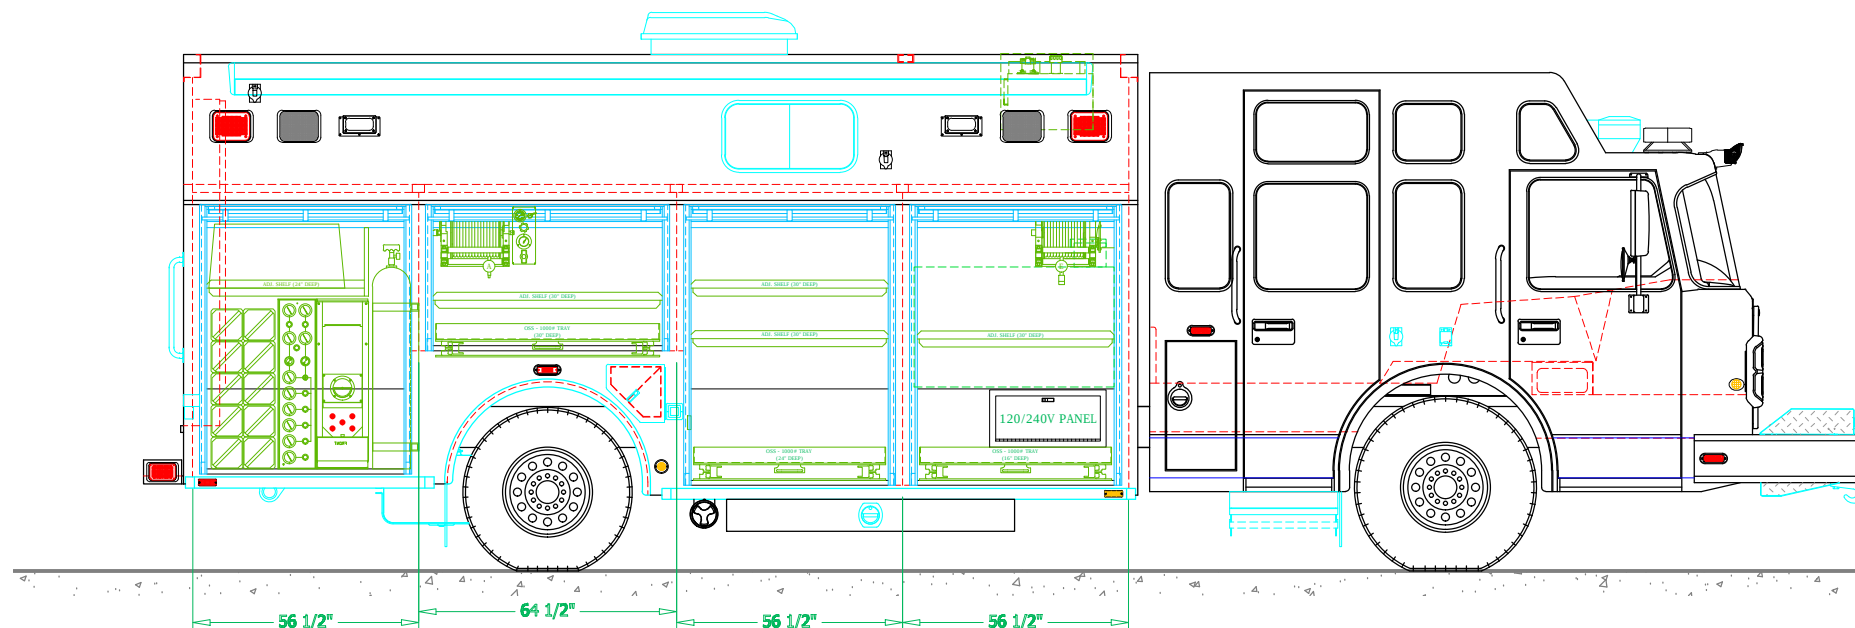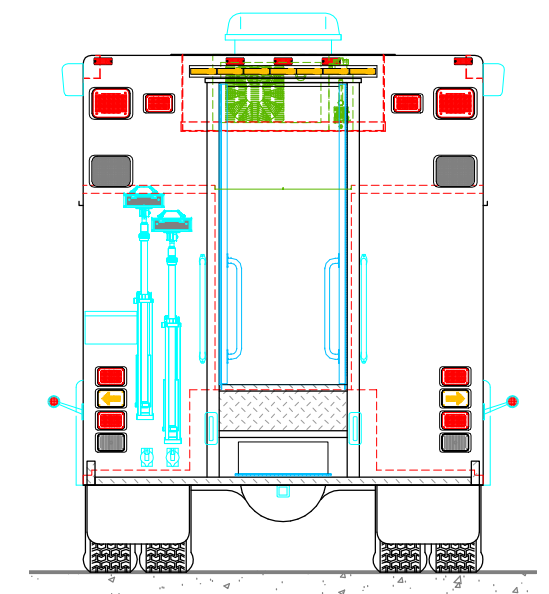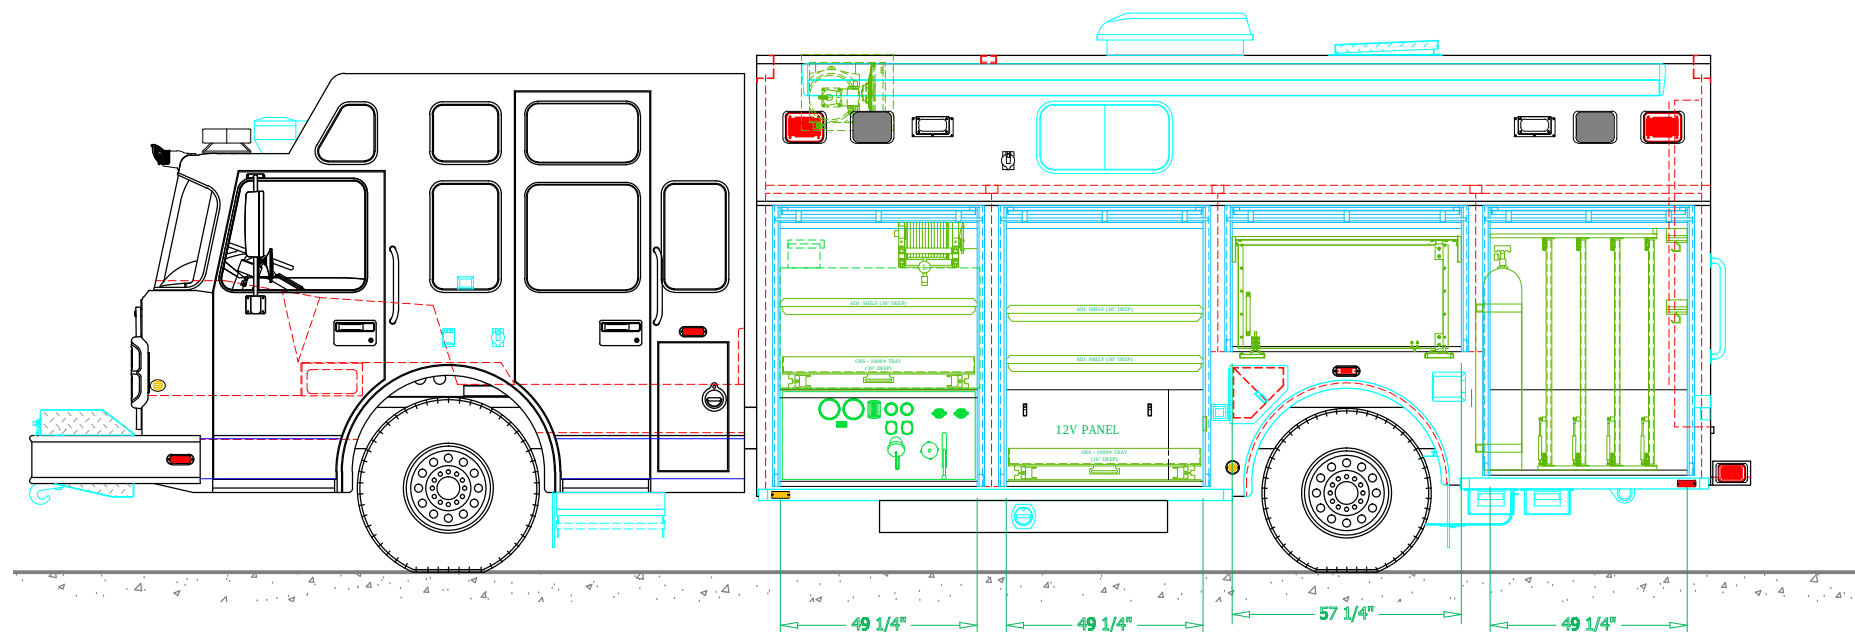

1511 E. 11th STREET, LOVELAND, CO 80537 PHONE 970-667-5146, FAX 970-667-3343

ABERDEEN
FIRE DISTRICT #1

DRAWING NO: Aberdeen_NJ_hr_PCM1


SHEET 2 OF 3

PRELIMINARY DRAWING - FOR LAYOUT PURPOSES ONLY


REVISIONS			
REV	DESCRIPTION	DATE	BY

NOTE 1: Do not scale drawing. This drawing is for general truck configuration only. All items and dimensions shown are approximate and may vary with final production. The drawing may not provide illustration for all items in the specification. In all situations where the drawing may contradict the specifications, the specifications shall prevail. This drawing and all data herein are provided as confidential materials and shall not be reproduced without written consent of the manufacturer.


PLAN VIEW
CROSS-SECTION

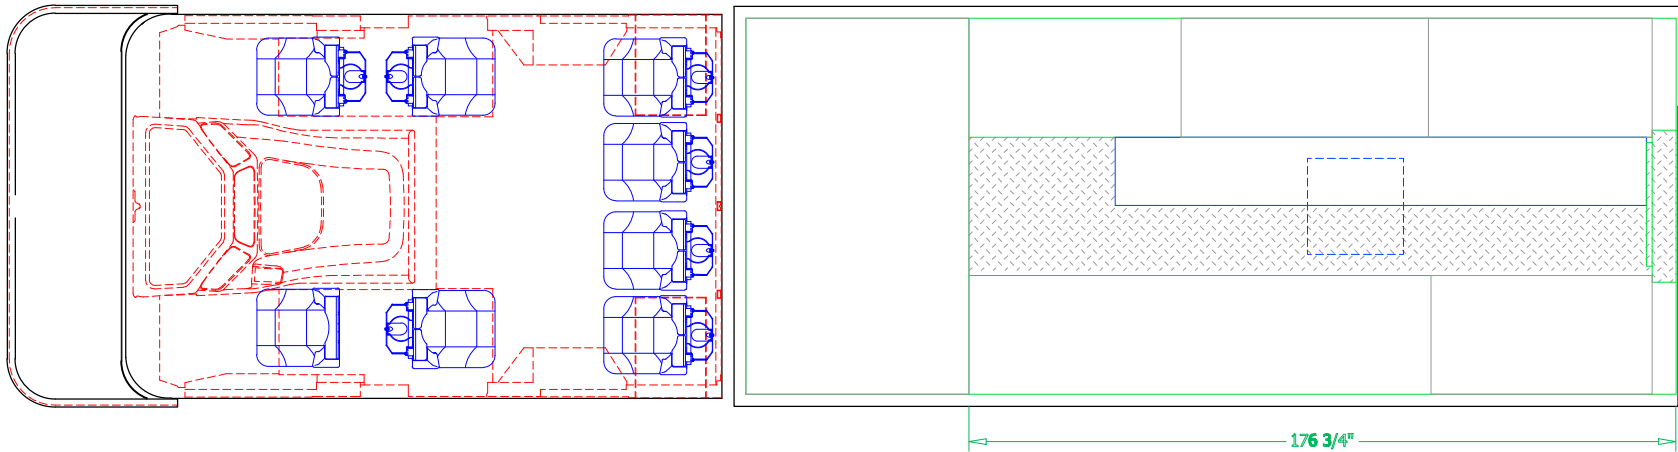


CURBSIDE INTERIOR
CROSS-SECTION

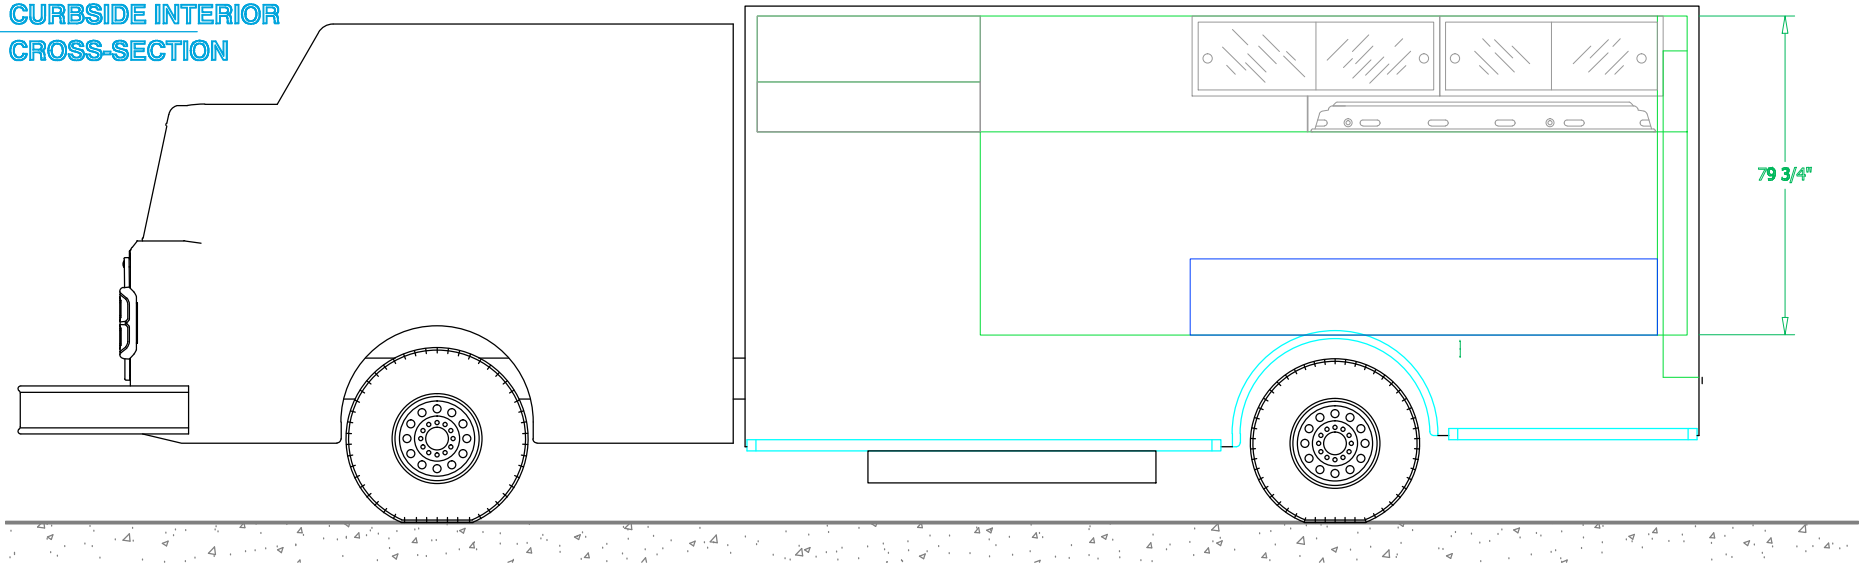


REAR VIEW
CROSS-SECTION

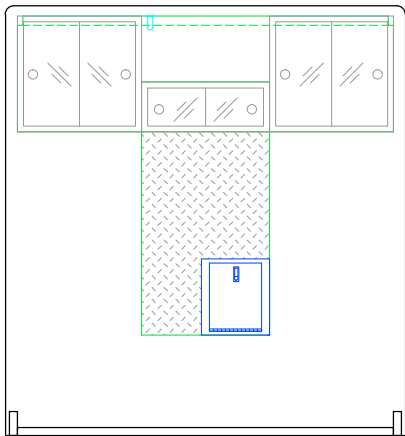

STREETSIDE INTERIOR
CROSS-SECTION

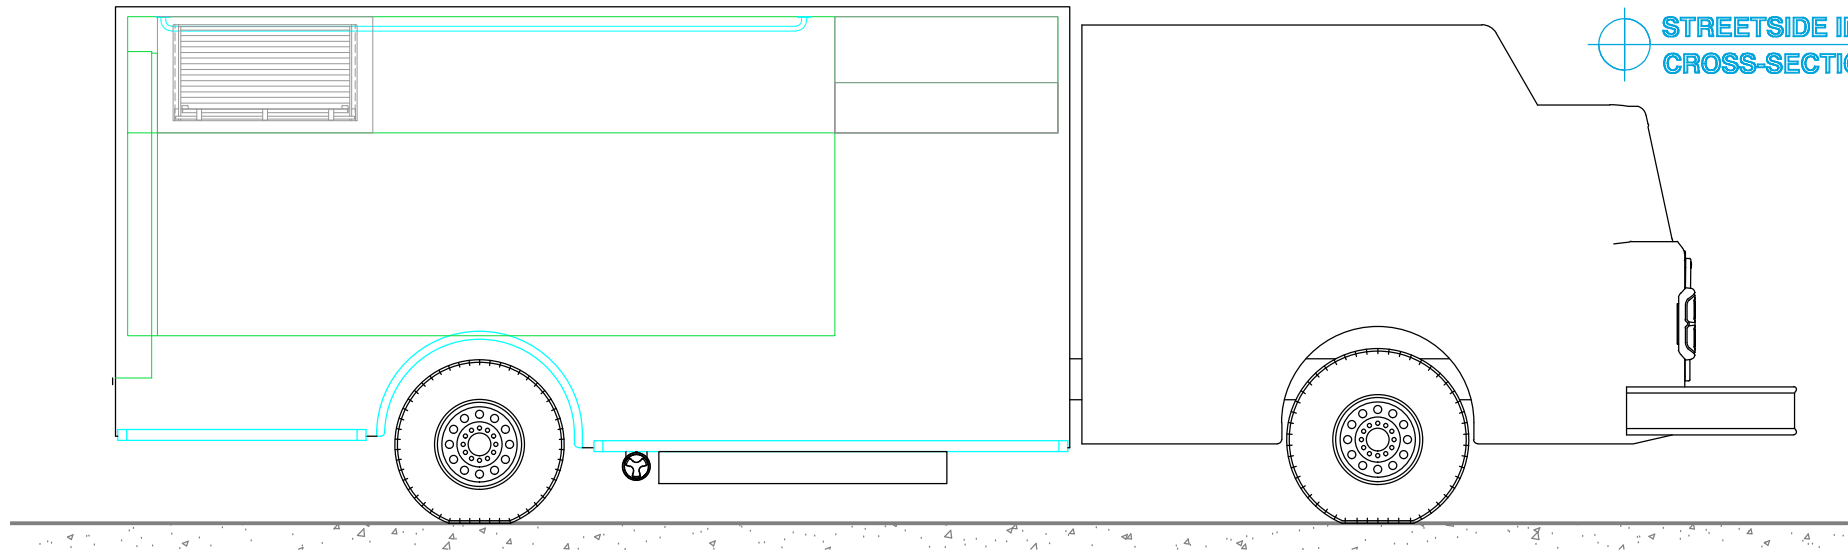

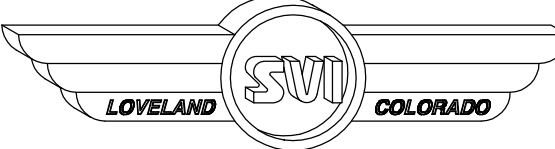

LOVELAND SVI COLORADO

SVI FIRE & RESCUE TRUCKS
1511 E. 11th STREET, LOVELAND, CO 80537 PHONE 970-667-5146, FAX 970-667-3343

**ABERDEEN
FIRE DISTRICT #1**

DRAWN BY: HJR	DATE: September 25, 2013	SCALE: 1/4" = 1'-0"
DRAWING NO: Aberdeen_NJ_hr_PDM1		SHEET 3 OF 3